


Luminaire Location Summary	Z
Project: 04 TRUNNION FLOOR LEVEL RL +4245	
LumNo	Label
99	Em-W/20 CFL
100	Em-W/20 CFL
101	Em-W/20 CFL
102	Em-W/20 CFL
103	Em-W/20 CFL
104	Em-W/20 CFL
105	Em-W/20 CFL
106	Em-W/20 CFL
107	Em-W/20 CFL
108	Em-W/20 CFL
109	Em-W/20 CFL
110	Em-W/20 CFL
111	Em-W/20 CFL
112	Em-W/20 CFL
113	Em-W/20 CFL
114	New Em-W-Right
115	New Em-W/20 CFL
116	New Em-W/20 CFL
117	New Em-W/20 CFL
118	New Em-W/20 CFL
119	New Em-W-Right
120	New Em-W-Right
121	Em-W/20 CFL
122	New Em-W-Left & Right

Luminaire Schedule			
Symbol	Qty	Label	
116	16	Em-W/20 CFL	
119	1	New Em-W/20 CFL	
120	4	New Em-W/20 CFL	
121	2	New Em-W-Right	
122	1	New Em-W-Left & Right	

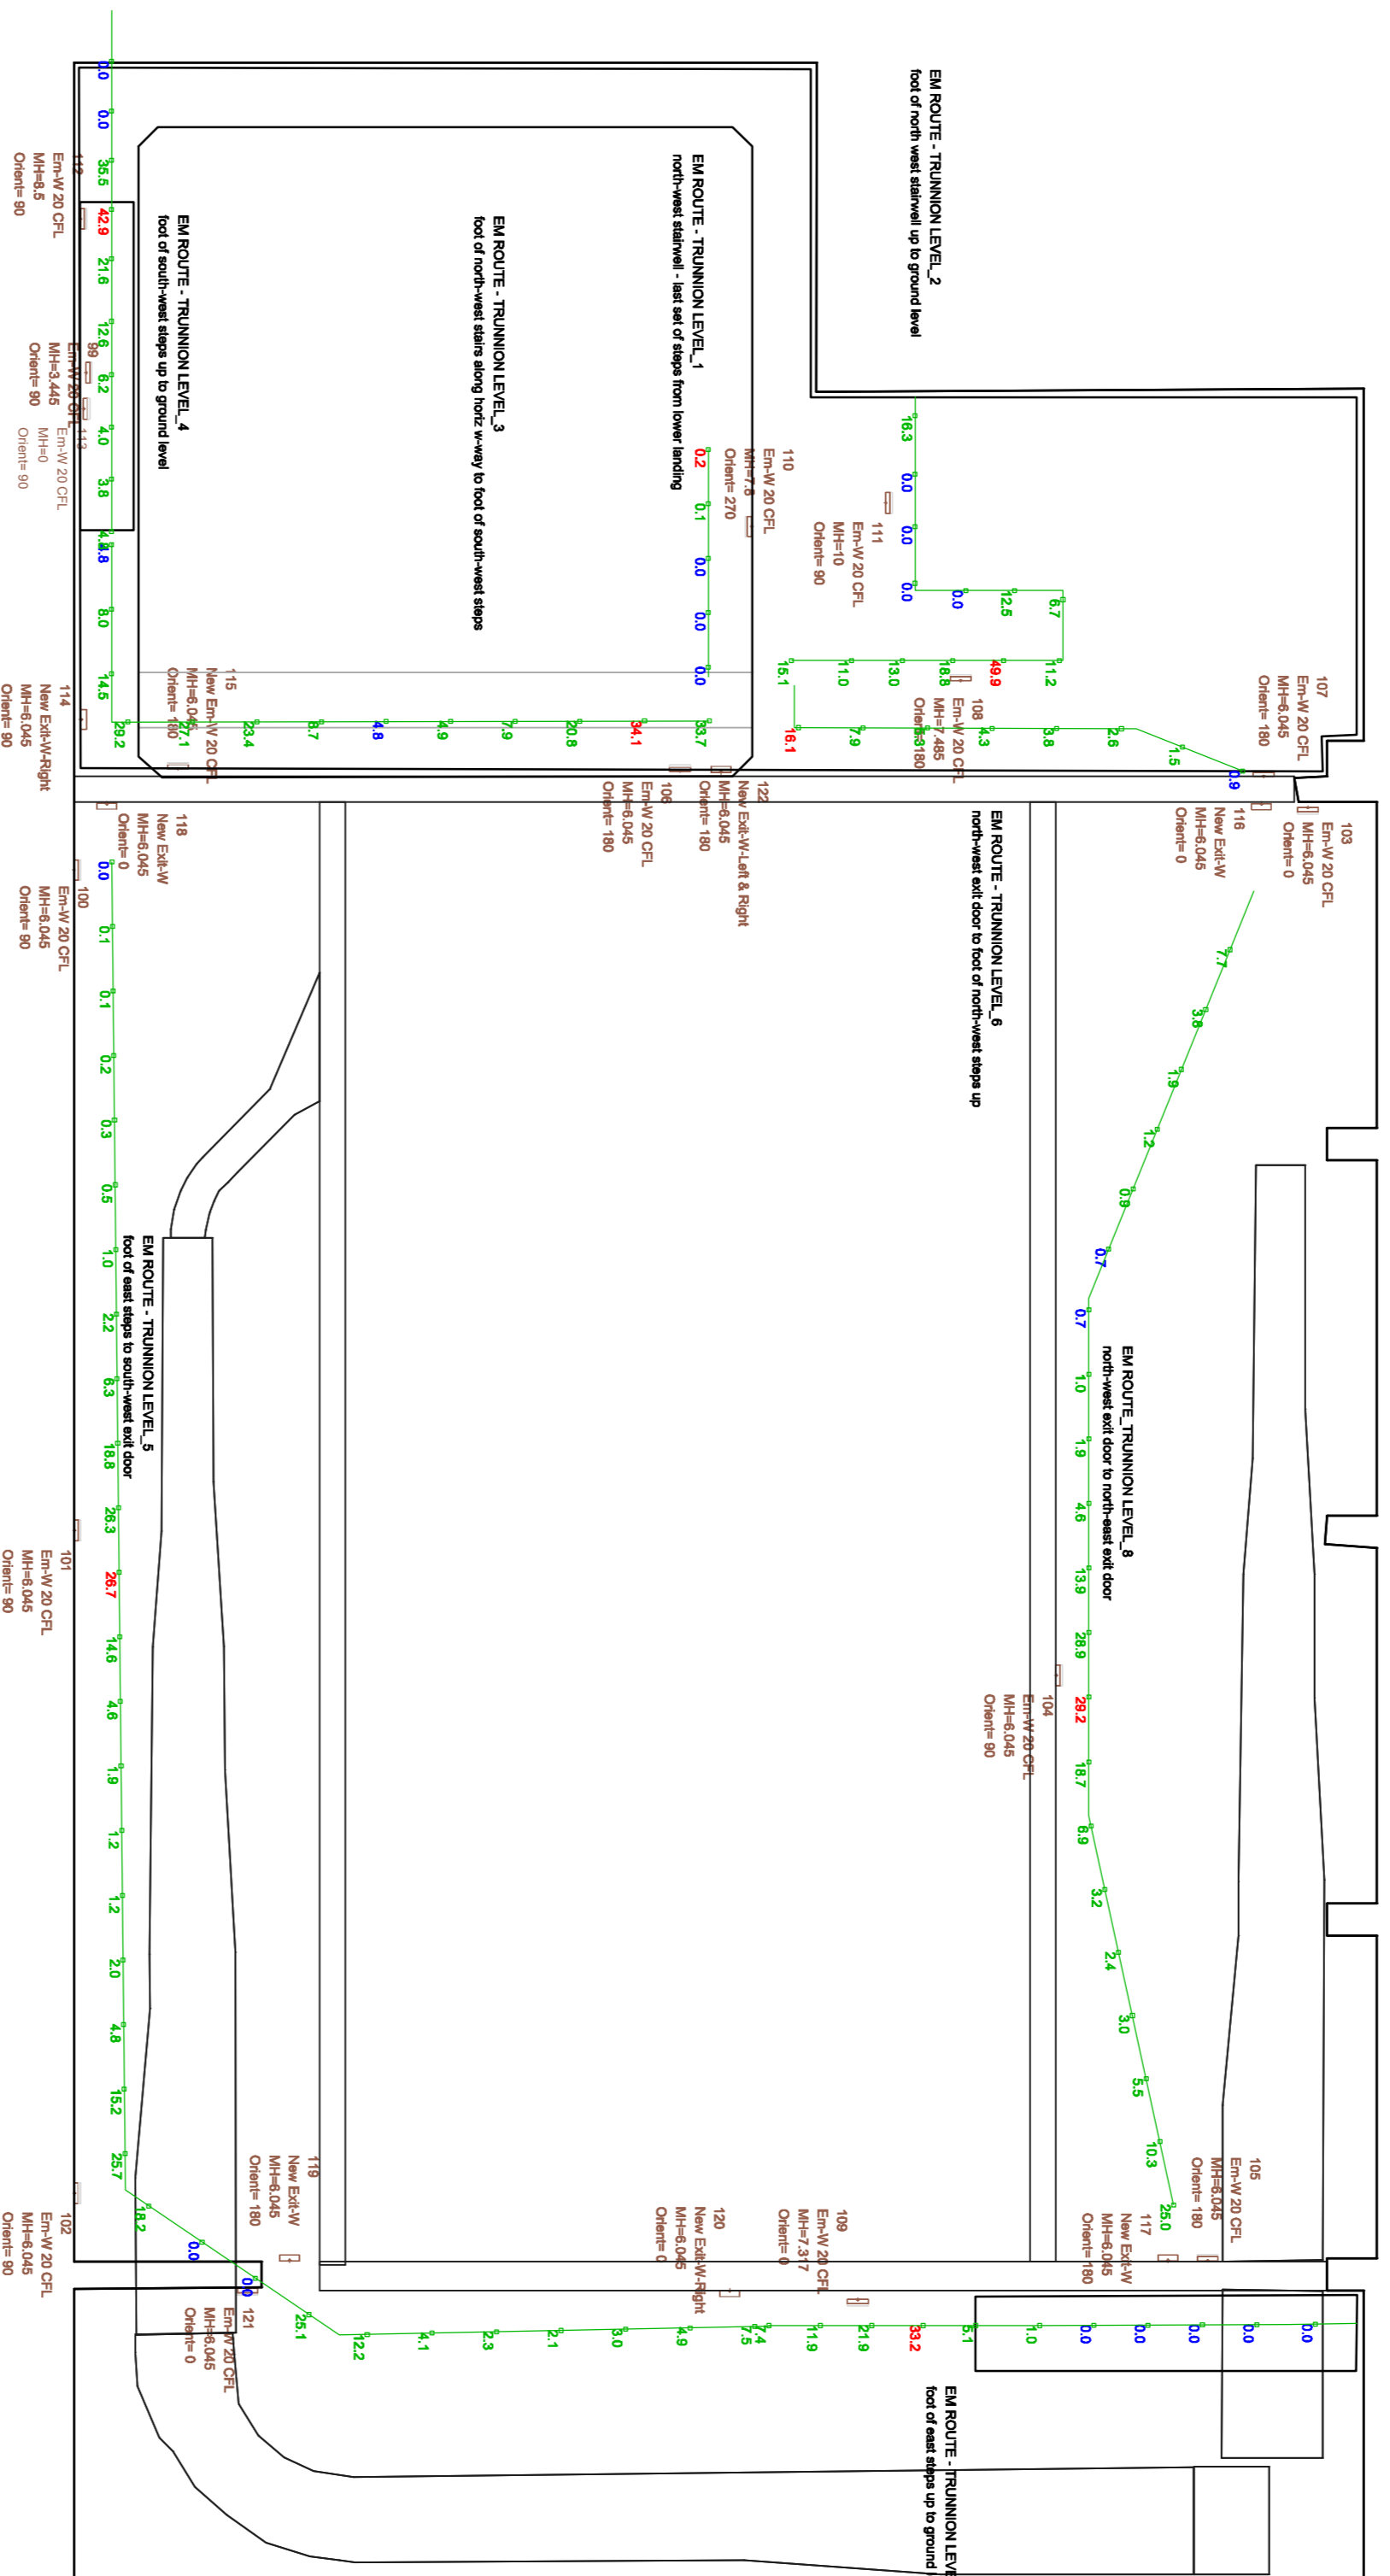

TRUNNION LEVEL
stairwell openings in floor & ceiling
04 TRUNNION FLOOR LEVEL RL +4245

REV	DATE	COMMENTS	W/S	J/W	BY	CHK
0	13.03.07	INITIAL ISSUE				



www.lightplan.net
 iplan@lightplan.net.au
 10 THE RIDGE
 WESTERN AUSTRALIA
 PORT ORE HANDLING
 NO 3 CAR DUMPER
 TRUNNION LEVEL
 ILLUMINANCE PREDICTIONS AT PROPOSED
 EMERGENCY ESCAPE ROUTES

BRANW	DESIGNED	J/W	REDUCION	SHEET SIZE
DESIGNED	J/W	PRINCIPAL	8	A1
APPROVED	J/W		25	
SCALE	1:100			
DATE	13.03.07			
DRAWING NO.				
JOB NO.	128B			
				L04
				0